



1700Z

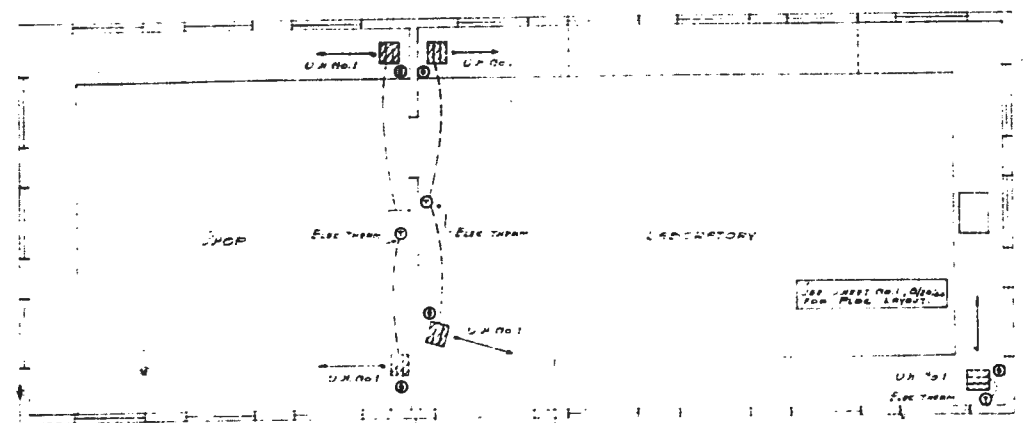


21. Elec. Plan for Wiring

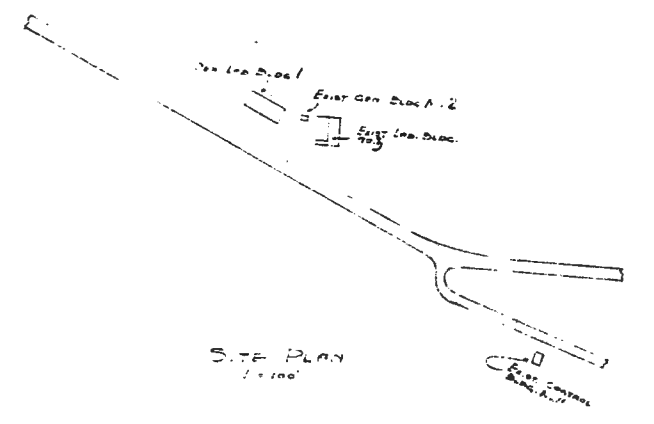

Site Plan


UNIT HEATING No. 1
FORCED CONNECTION TYPE
CEILING SUSPENDED
3 INCH DIA. - 18' 00" CYCLE
1000 B.T.U. - 210 C.F.M.
100' x 75' AIR TEMP
ELECTRIC THERMOSTATS
CR-1066-210

NEW LABORATORY BUILDING No. 1
- ELEC. HEATING
SCALE 1/4" = 1'-0"

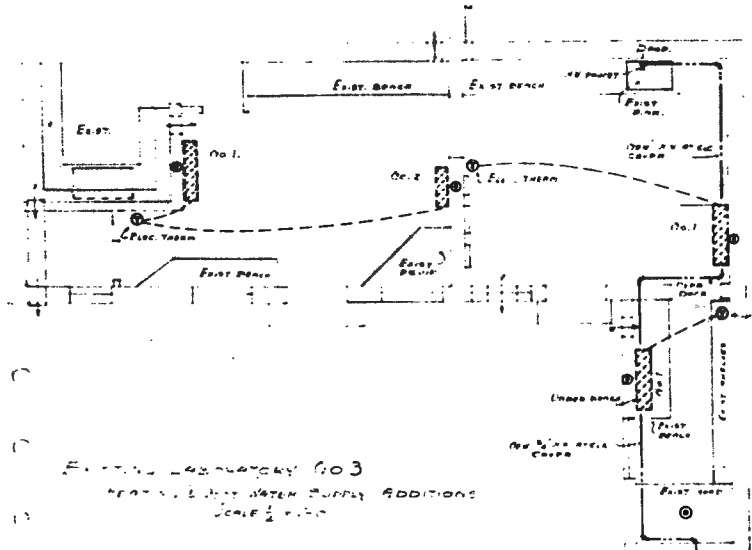

Existing Laboratory No. 3
HEATING UNIT WATER SUPPLY ADDITIONS
SCALE 1/4" = 1'-0"

ELECTRIC HEAT, NO. 1
No. 1
No. 2
No. 3
No. 4
No. 5
No. 6
No. 7
No. 8
No. 9
No. 10
No. 11
No. 12
No. 13
No. 14
No. 15
No. 16
No. 17
No. 18
No. 19
No. 20
No. 21
No. 22
No. 23
No. 24
No. 25
No. 26
No. 27
No. 28
No. 29
No. 30

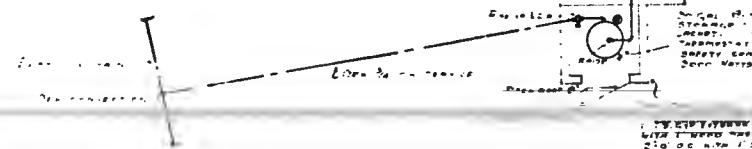

NOTE: SEE DRAWING FOR
STANDARD AND SPECIFIC
CONNECTIONS AND FOR
TOLERANCES AND FOR
DIMENSIONS AND FOR
MATERIALS AND FOR
CONSTRUCTION NOTES
DRAWN BY: J.C.H. 12/18/70
CHECKED BY: J.C.H.

BUILDING 183 HEATING - PLUMBING

W.C. KRUGER ARCHITECT	ZIA PROJECT	DRAWN: ESR
APPROVED: <i>[Signature]</i>	2 MILE MESA CONSTRUCTION	DATE: 12/18/70
OPERATIONS OFFICER: <i>[Signature]</i>	ENGINEER OFFICE	CHECKED: <i>[Signature]</i>
	SANTA FE	SHEET NO. 2
	NEW MEXICO	

L.A.S.I. DWG. NO. ENG-C 1624

3027



6011